


SYMBOL	REVISIONS	DATE	ENG

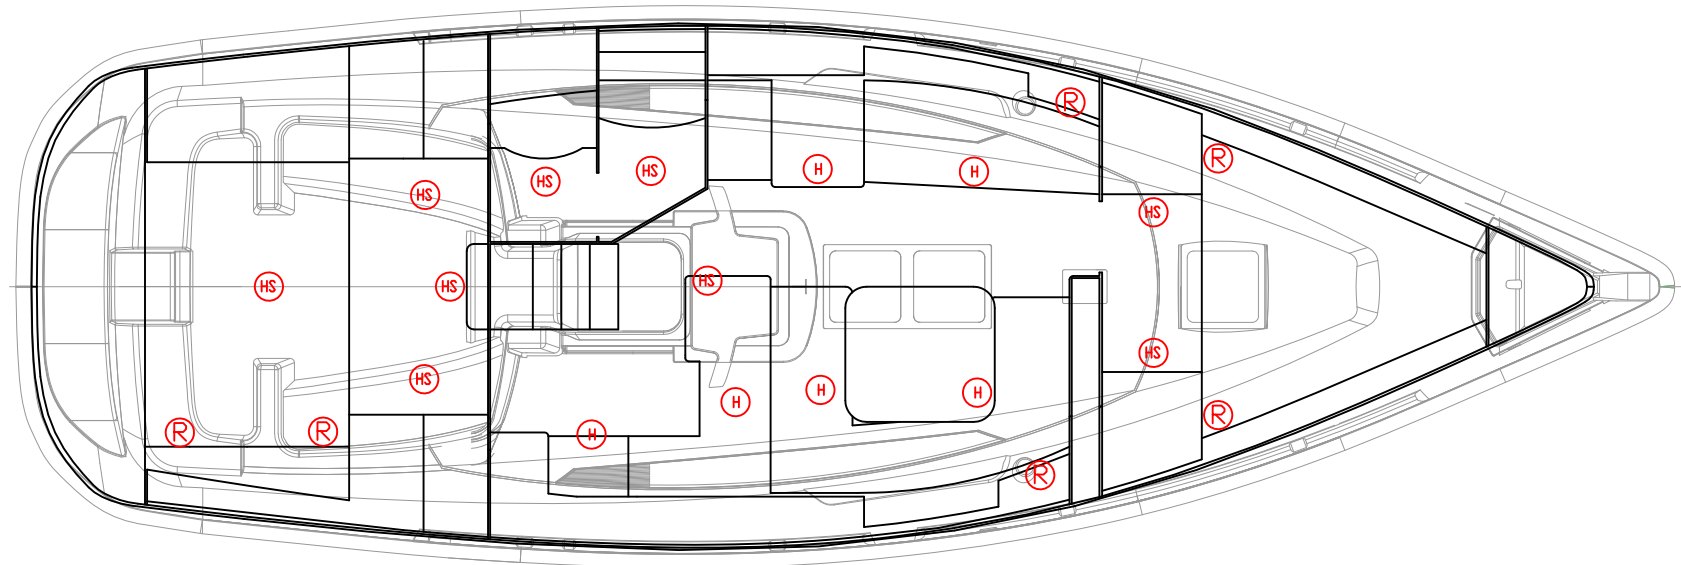

- (H) HALOGEN W/D SWITCH 6 ea.
- (R) SWIVEL READING LIGHT 6 ea.
- (HS) HALOGEN W/SWITCH 9 ea.

PROPRIETARY INFORMATION: THIS DRAWING CONTAINS INFORMATION FOR WHICH HUNTER MARINE CORPORATION HAS PROPRIETARY RIGHTS.


H U N T E R
39

DRAWING TITLE: LIGHTING LAYOUT

DRAWN BY:	JLK	DATE:	JUNE-11-2009	SHEET	1	OF	1
SCALE:	HUNTER PART NO.	REVISION		DRAW #	39 LIGHTING LAYOUT		

CHECKED